



Tim O'Malley, Architects
 Architecture & Planning
 432 South 14th Street
 St. Charles, IL 60174
 Ph: 630-762-1062

Pet Pals Tenant Buildout
 Dodson Place Building 8, Geneva, Illinois

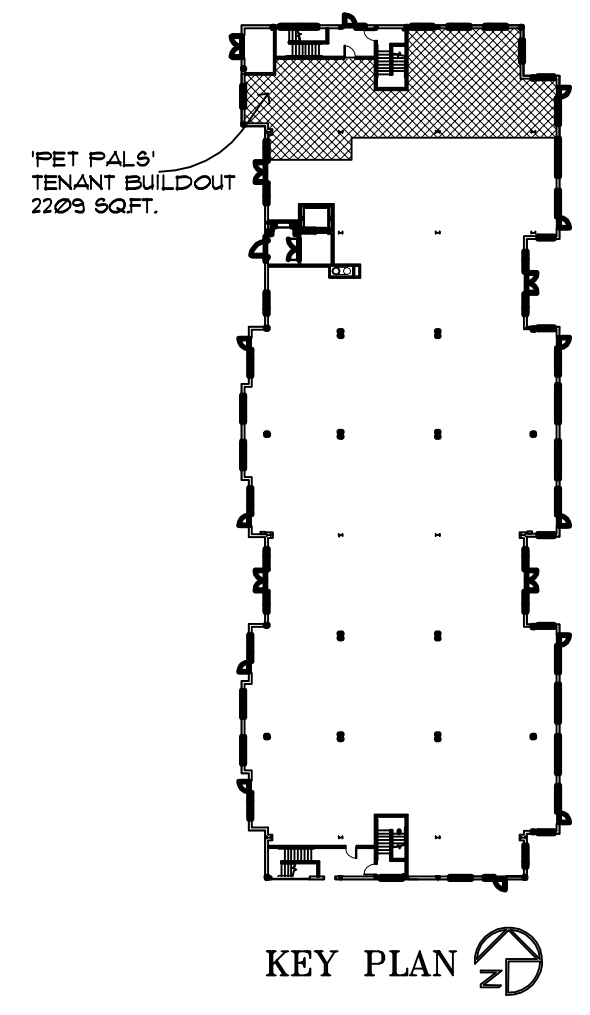

LIGHT FIXTURE SCHEDULE			
SYMBOL	MANUFACTURER	CATALOG #	DESCRIPTION
[Symbol: 2'x4' Lay-in Fluor. Fixture]	LITHONIA	TBD	2'x4' LAY-IN FLUOR. FIXTURE, 3 LAMP HEAVY DUTY ACRYLIC DIFFUSER
[Symbol: Recessed Can Fixture]	TBD	TBD	RECESSED CAN FIXTURE
[Symbol: Recessed Can Fixture (Store Type)]	TBD	TBD	RECESSED CAN FIXTURE (STORE TYPE)
[Symbol: Emergency Exit Light]	SURE-LITES	EAC SERIES	EMERGENCY EXIT LIGHTS
[Symbol: Combination Exit/Emergency Light]	SURE-LITES	UNISRWDH	COMBINATION EXIT/EMERGENCY (BATTERY BACKUP)
[Symbol: Emergency Battery Pack]	SURE-LITES	XR SERIES	EMERGENCY BATTERY PACKS

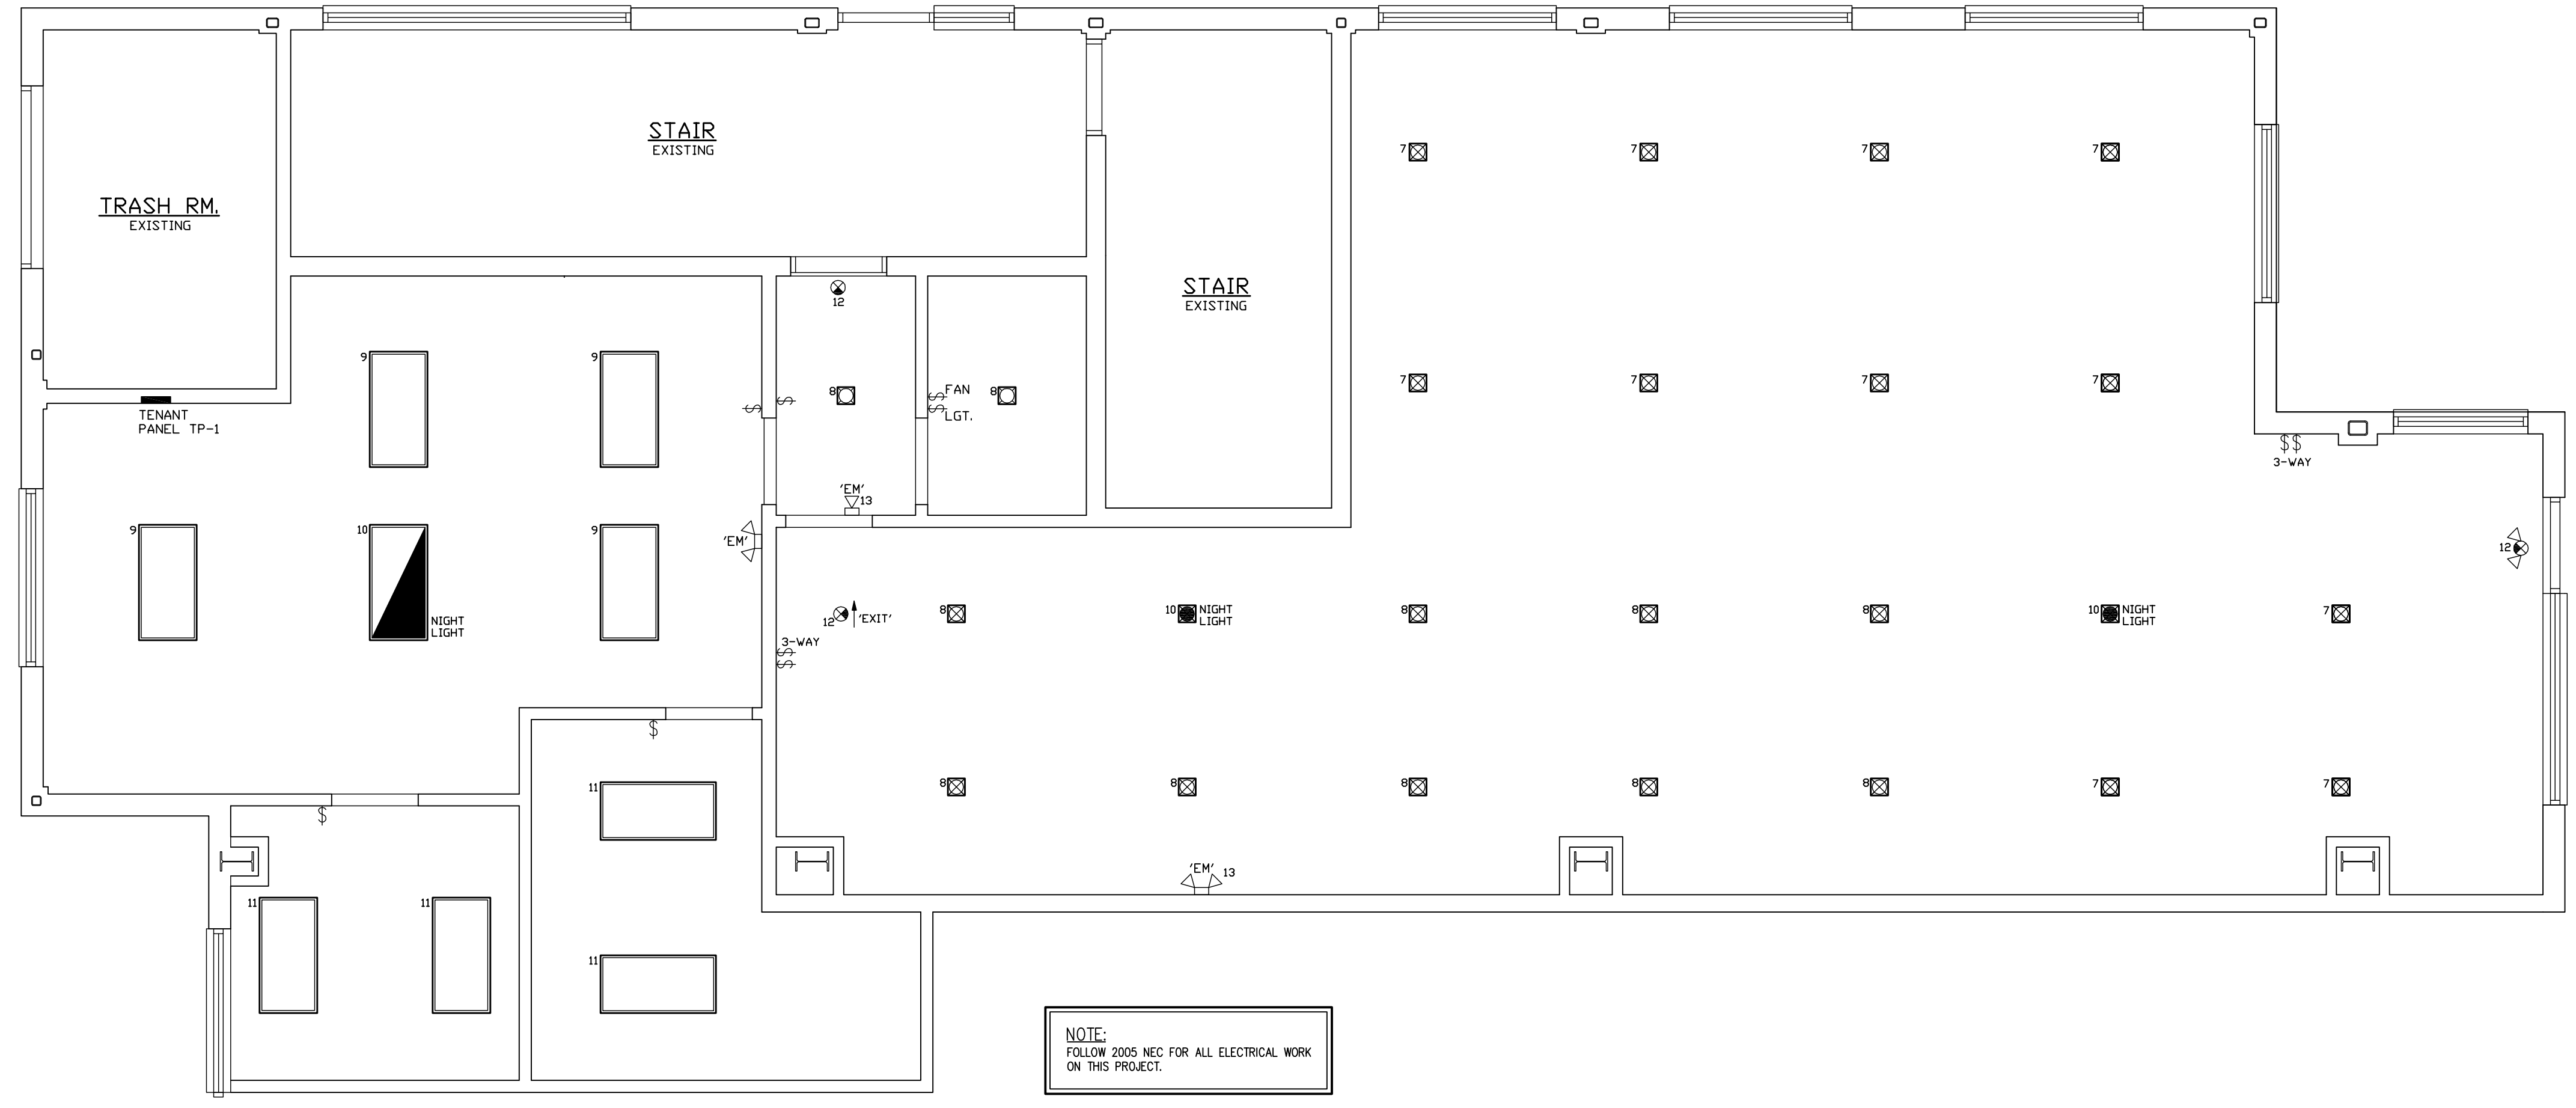

LIGHTING PLAN
 SCALE: 1/4" = 1'-0"

Revisions

© COPYRIGHT 2010 BY TIM O'MALLEY, ARCHITECTS
 ALL RIGHTS RESERVED

Plotted: APRIL 6, 2010
 Issue Date: MARCH 16, 2010
 Drawn: J.KIDD
 Job No:

JKS & Associates
 MECHANICAL ENGINEERS
 3S094 Deepath Road
 Batavia, Illinois 60510
 Ph: 630-879-2957

Sheet No:
E2
 of